

BEAZER ENGINEERING INC.
 P.O. BOX 652
 MILLVILLE, UTAH 84326
 C 435.770.8999
 david@beazer-engineering.com

OWNERSHIP OF DOCUMENTS
 These documents, including the designs and ideas incorporated herein, are the property of BEAZER ENGINEERING, INC. and shall not be used, in whole or in part, for any other project without written permission.

DATE
 Jan 6, 2023

PROJECT TITLE
 Logan City School District
 Main Office Remodel
 101 West Center
 Logan, Utah 84321

SHEET TITLE
 LOWER FLOOR
 LIGHTING PLAN

PROJECT NUMBER

REVISIONS

SHEET NUMBER

E1.1


KEYED NOTES


1. REPLACE EXISTING FIXTURE WITH NEW IN APPROXIMATELY SAME LOCATION.
2. NEW FIXTURE LOCATION.
3. REPLACE "A" LAMP WITH 15W LED A21 LAMP.

NOTE- PARTIAL REPLACEMENT FIXTURES SHOWN. STAIRS AND SOME LOBBY AREAS NOT INCLUDED YET.

| LIGHT FIXTURE SCHEDULE | | | |
|------------------------|---|--------------------------|-----------|
| TYPE | MANUFACTURER/CATALOG NO. | MOUNTING | LAMPS |
| T1 | LITHONIA EPANL 2X2 3400LM 80CRI 35K MIN10 ZT MVOLT | T-BAR | LED (30W) |
| T1E | SAME AS T1 WITH E10WCP EMERGENCY BATTERY PACK | T-BAR | LED (30W) |
| T2 | LITHONIA CLX L48 3000LM SEF WDL MVOLT G210 35KI 80CRI | SURFACE OR CHAIN SUSPEND | LED (19W) |
| T2E | SAME AS T2 WITH E10WCP EMERGENCY BATTERY PACK | SURFACE OR CHAIN SUSPEND | LED (19W) |
| T3 | LITHONIA STL4 30L MVOLT EZ1 LP835 | SURFACE | LED (27W) |
| T3E | SAME AS T3 WITH EL14L EMERGENCY BATTERY PACK | SURFACE | LED (27W) |
| T4 | LITHONIA STL4 60L MVOLT EZ1 LP835 | SURFACE | LED (53W) |
| T5 | LITHONIA STL2 20L MVOLT EZ1 LP835 | SURFACE | LED (20W) |
| T6 | LITHONIA EPANL 2X2 4000LM 80CRI 35K MIN10 ZT MVOLT | T-BAR | LED (37W) |
| T6E | SAME AS T6 WITH E10WCP EMERGENCY BATTERY PACK | T-BAR | LED (37W) |
| T7 | LITHONIA EPANL 2X2 4800LM 80CRI 35K MIN10 ZT MVOLT | T-BAR | LED (45W) |
| T8 | BATHROOM WALL ABOVE MIRROR | WALL ABOVE MIRROR | LED (30W) |
| T9 | GOTHAM EVO 35/15 AR LD WD MVOLT G21 | RECESS | LED (15W) |

EQUAL FIXTURES WITH SIMILAR LUMENS APPROVED BY OWNER ARE ACCEPTABLE

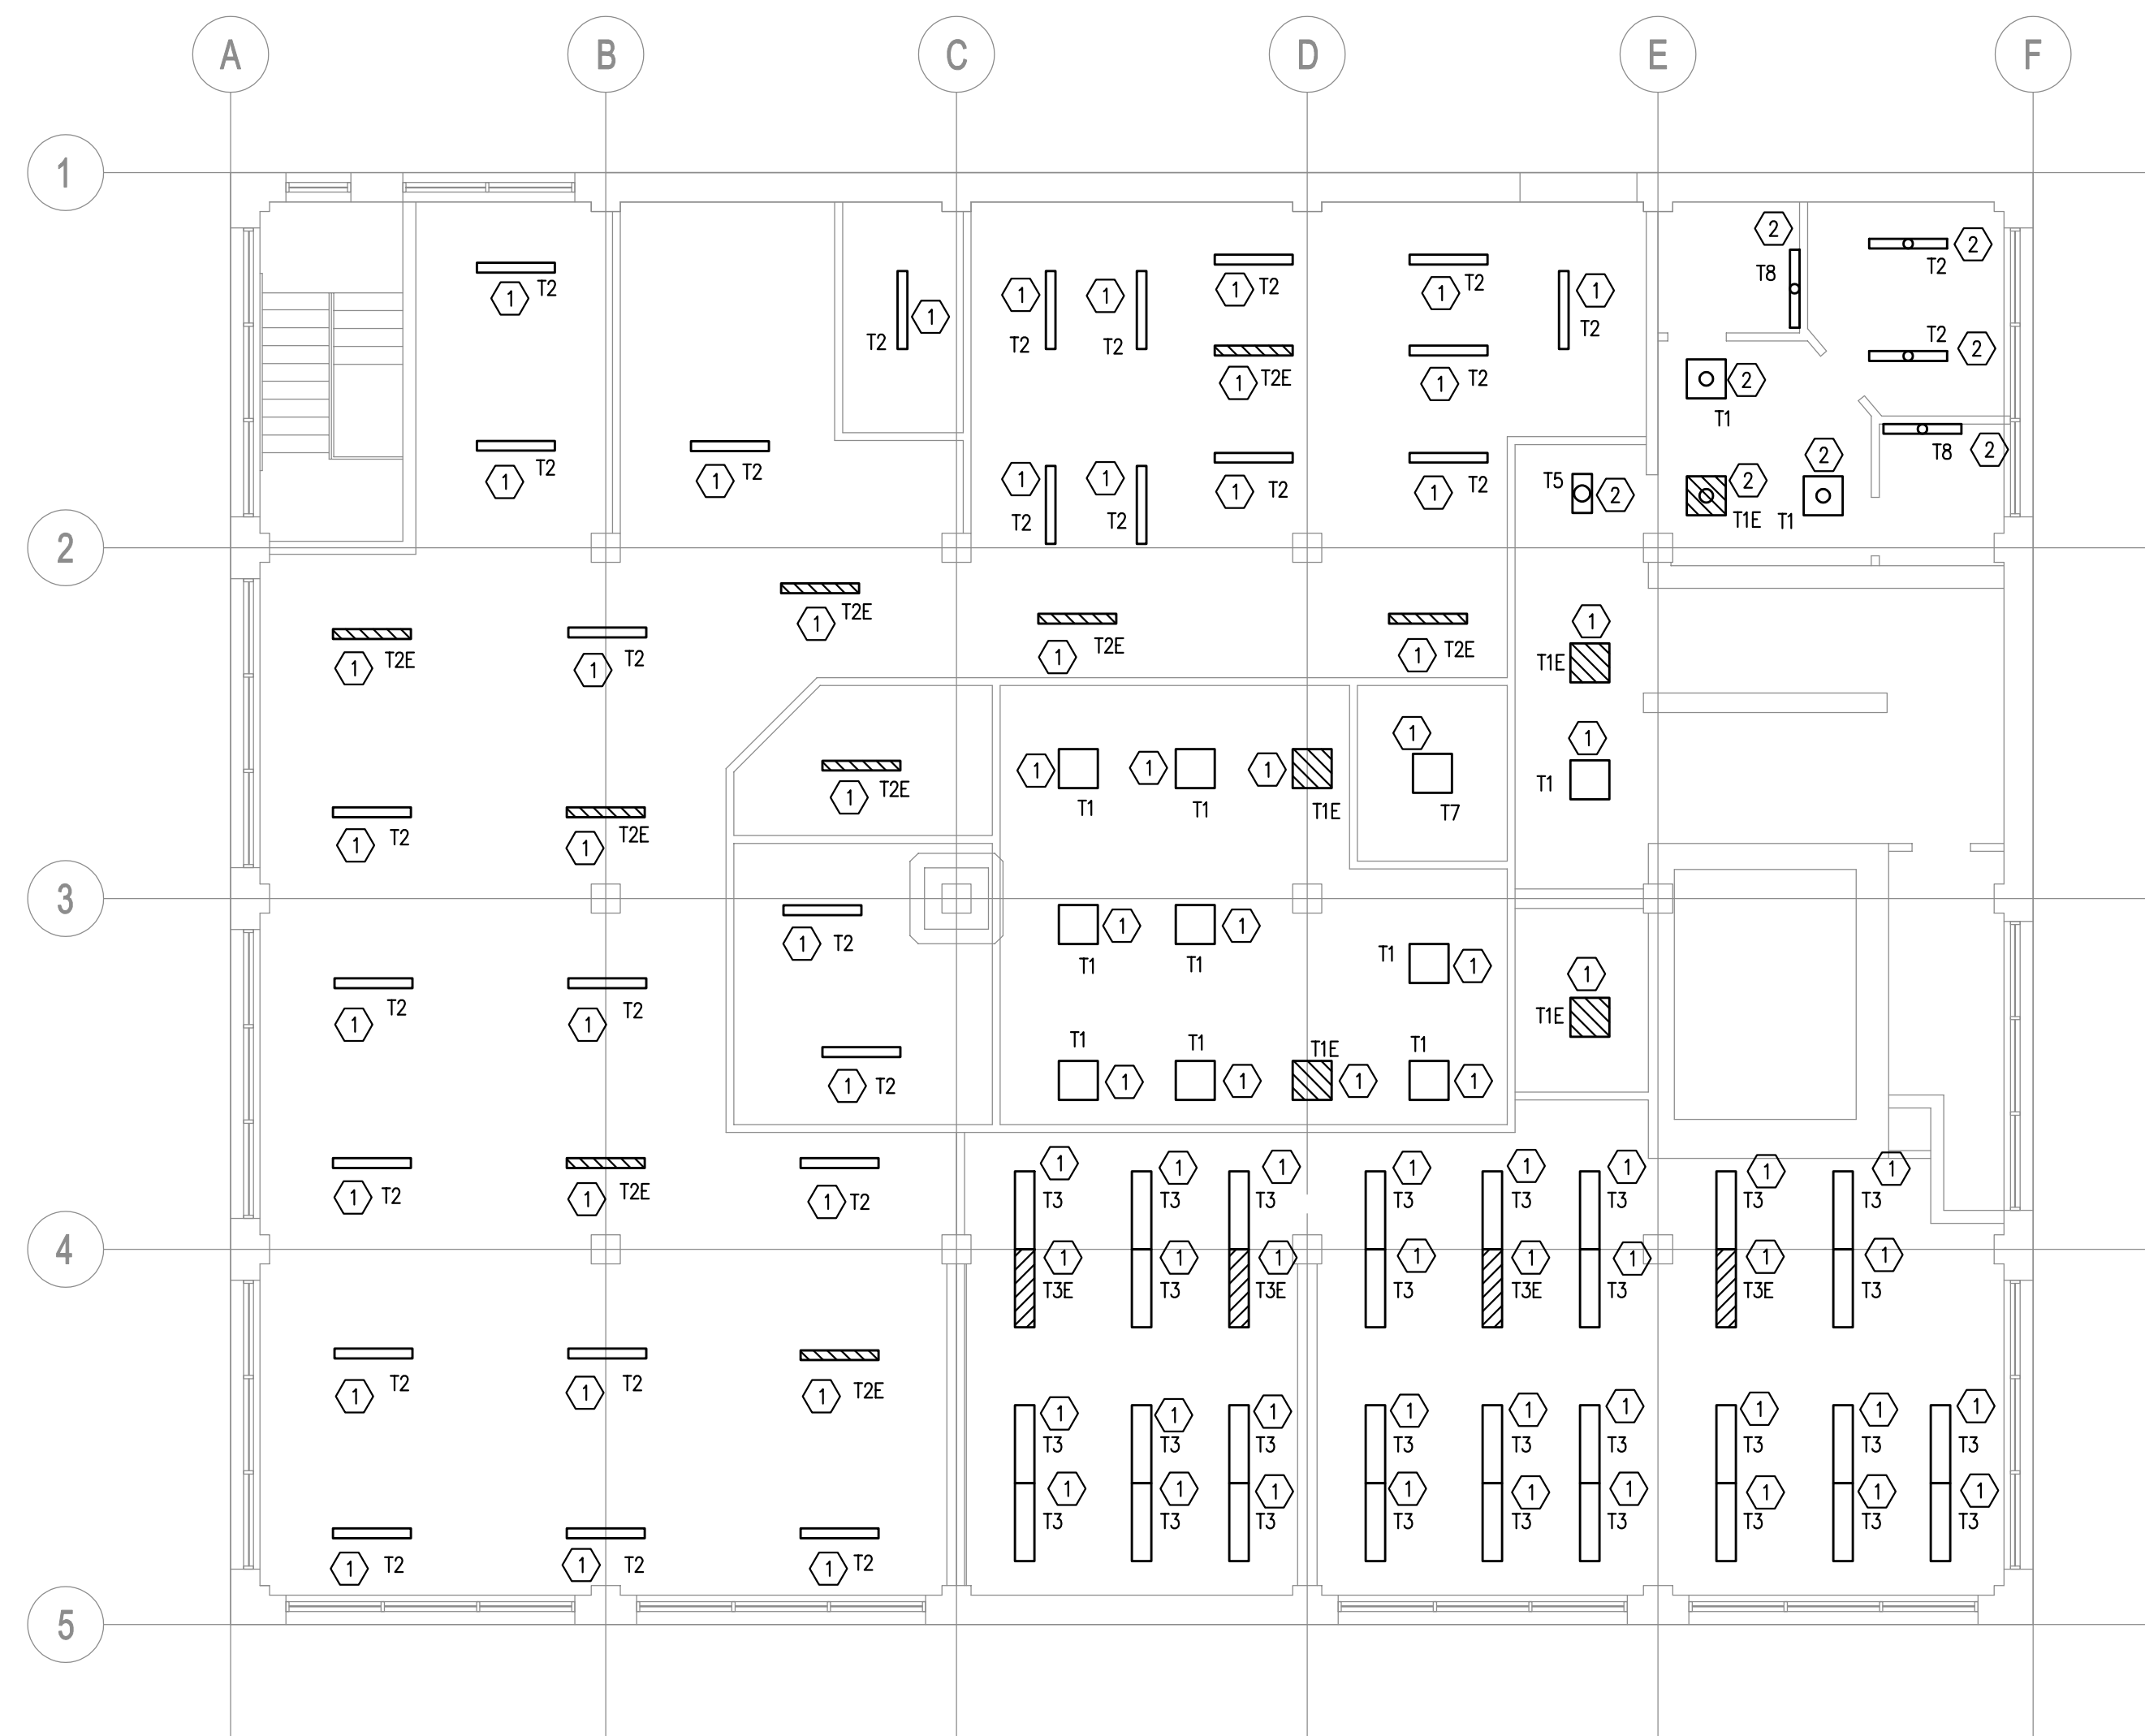

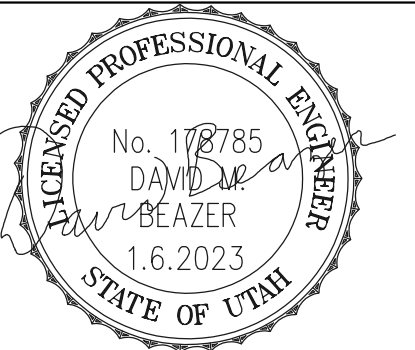

BEAZER ENGINEERING INC.
 P.O. BOX 652
 MILLVILLE, UTAH 84326
 C 435.770.8999
 david@beazer-engineering.com

OWNERSHIP OF DOCUMENTS
 These documents, including the designs and ideas incorporated herein, are the property of BEAZER ENGINEERING, INC. and shall not be used, in whole or in part, for any other project without written permission.

DATE
 Jan 6, 2023

PROJECT TITLE
 Logan City School District
 Main Office Remodel
 101 West Center
 Logan, Utah 84321

SHEET TITLE
 MAIN FLOOR
 LIGHTING PLAN

PROJECT NUMBER

REVISIONS

SHEET NUMBER


E1.2


KEYED NOTES (F)

1. REPLACE EXISTING FIXTURE WITH NEW IN APPROXIMATELY SAME LOCATION.
2. NEW FIXTURE LOCATION.
3. REPLACE "A" LAMP WITH 15W LED A21 LAMP.

| LIGHT FIXTURE SCHEDULE | | | |
|------------------------|---|--------------------------|-----------|
| TYPE | MANUFACTURER/CATALOG NO. | MOUNTING | LAMPS |
| T1 | LITHONIA EPANL 2X2 3400LM 80CRI 35K MIN10 ZT MVOLT | T-BAR | LED (30W) |
| T1E | SAME AS T1 WITH E10WCP EMERGENCY BATTERY PACK | T-BAR | LED (30W) |
| T2 | LITHONIA CLX L48 3000LM SEF WDL MVOLT G210 35KI 80CRI | SURFACE OR CHAIN SUSPEND | LED (19W) |
| T2E | SAME AS T2 WITH E10WCP EMERGENCY BATTERY PACK | SURFACE OR CHAIN SUSPEND | LED (19W) |
| T3 | LITHONIA STL4 30L MVOLT E21 LP835 | SURFACE | LED (27W) |
| T3E | SAME AS T3 WITH EL14L EMERGENCY BATTERY PACK | SURFACE | LED (27W) |
| T4 | LITHONIA STL4 60L MVOLT E21 LP835 | SURFACE | LED (53W) |
| T5 | LITHONIA STL2 20L MVOLT E21 LP835 | SURFACE | LED (20W) |
| T6 | LITHONIA EPANL 2X2 4000LM 80CRI 35K MIN10 ZT MVOLT | T-BAR | LED (37W) |
| T6E | SAME AS T6 WITH E10WCP EMERGENCY BATTERY PACK | T-BAR | LED (37W) |
| T7 | LITHONIA EPANL 2X2 4800LM 80CRI 35K MIN10 ZT MVOLT | T-BAR | LED (45W) |
| T8 | BATHROOM WALL ABOVE MIRROR | WALL ABOVE MIRROR | LED (30W) |
| T9 | GOATHAM EVO 35/15 AR LD WD MVOLT G21 | RECESS | LED (15W) |

EQUAL FIXTURES WITH SIMILAR LUMENS APPROVED BY OWNER ARE ACCEPTABLE

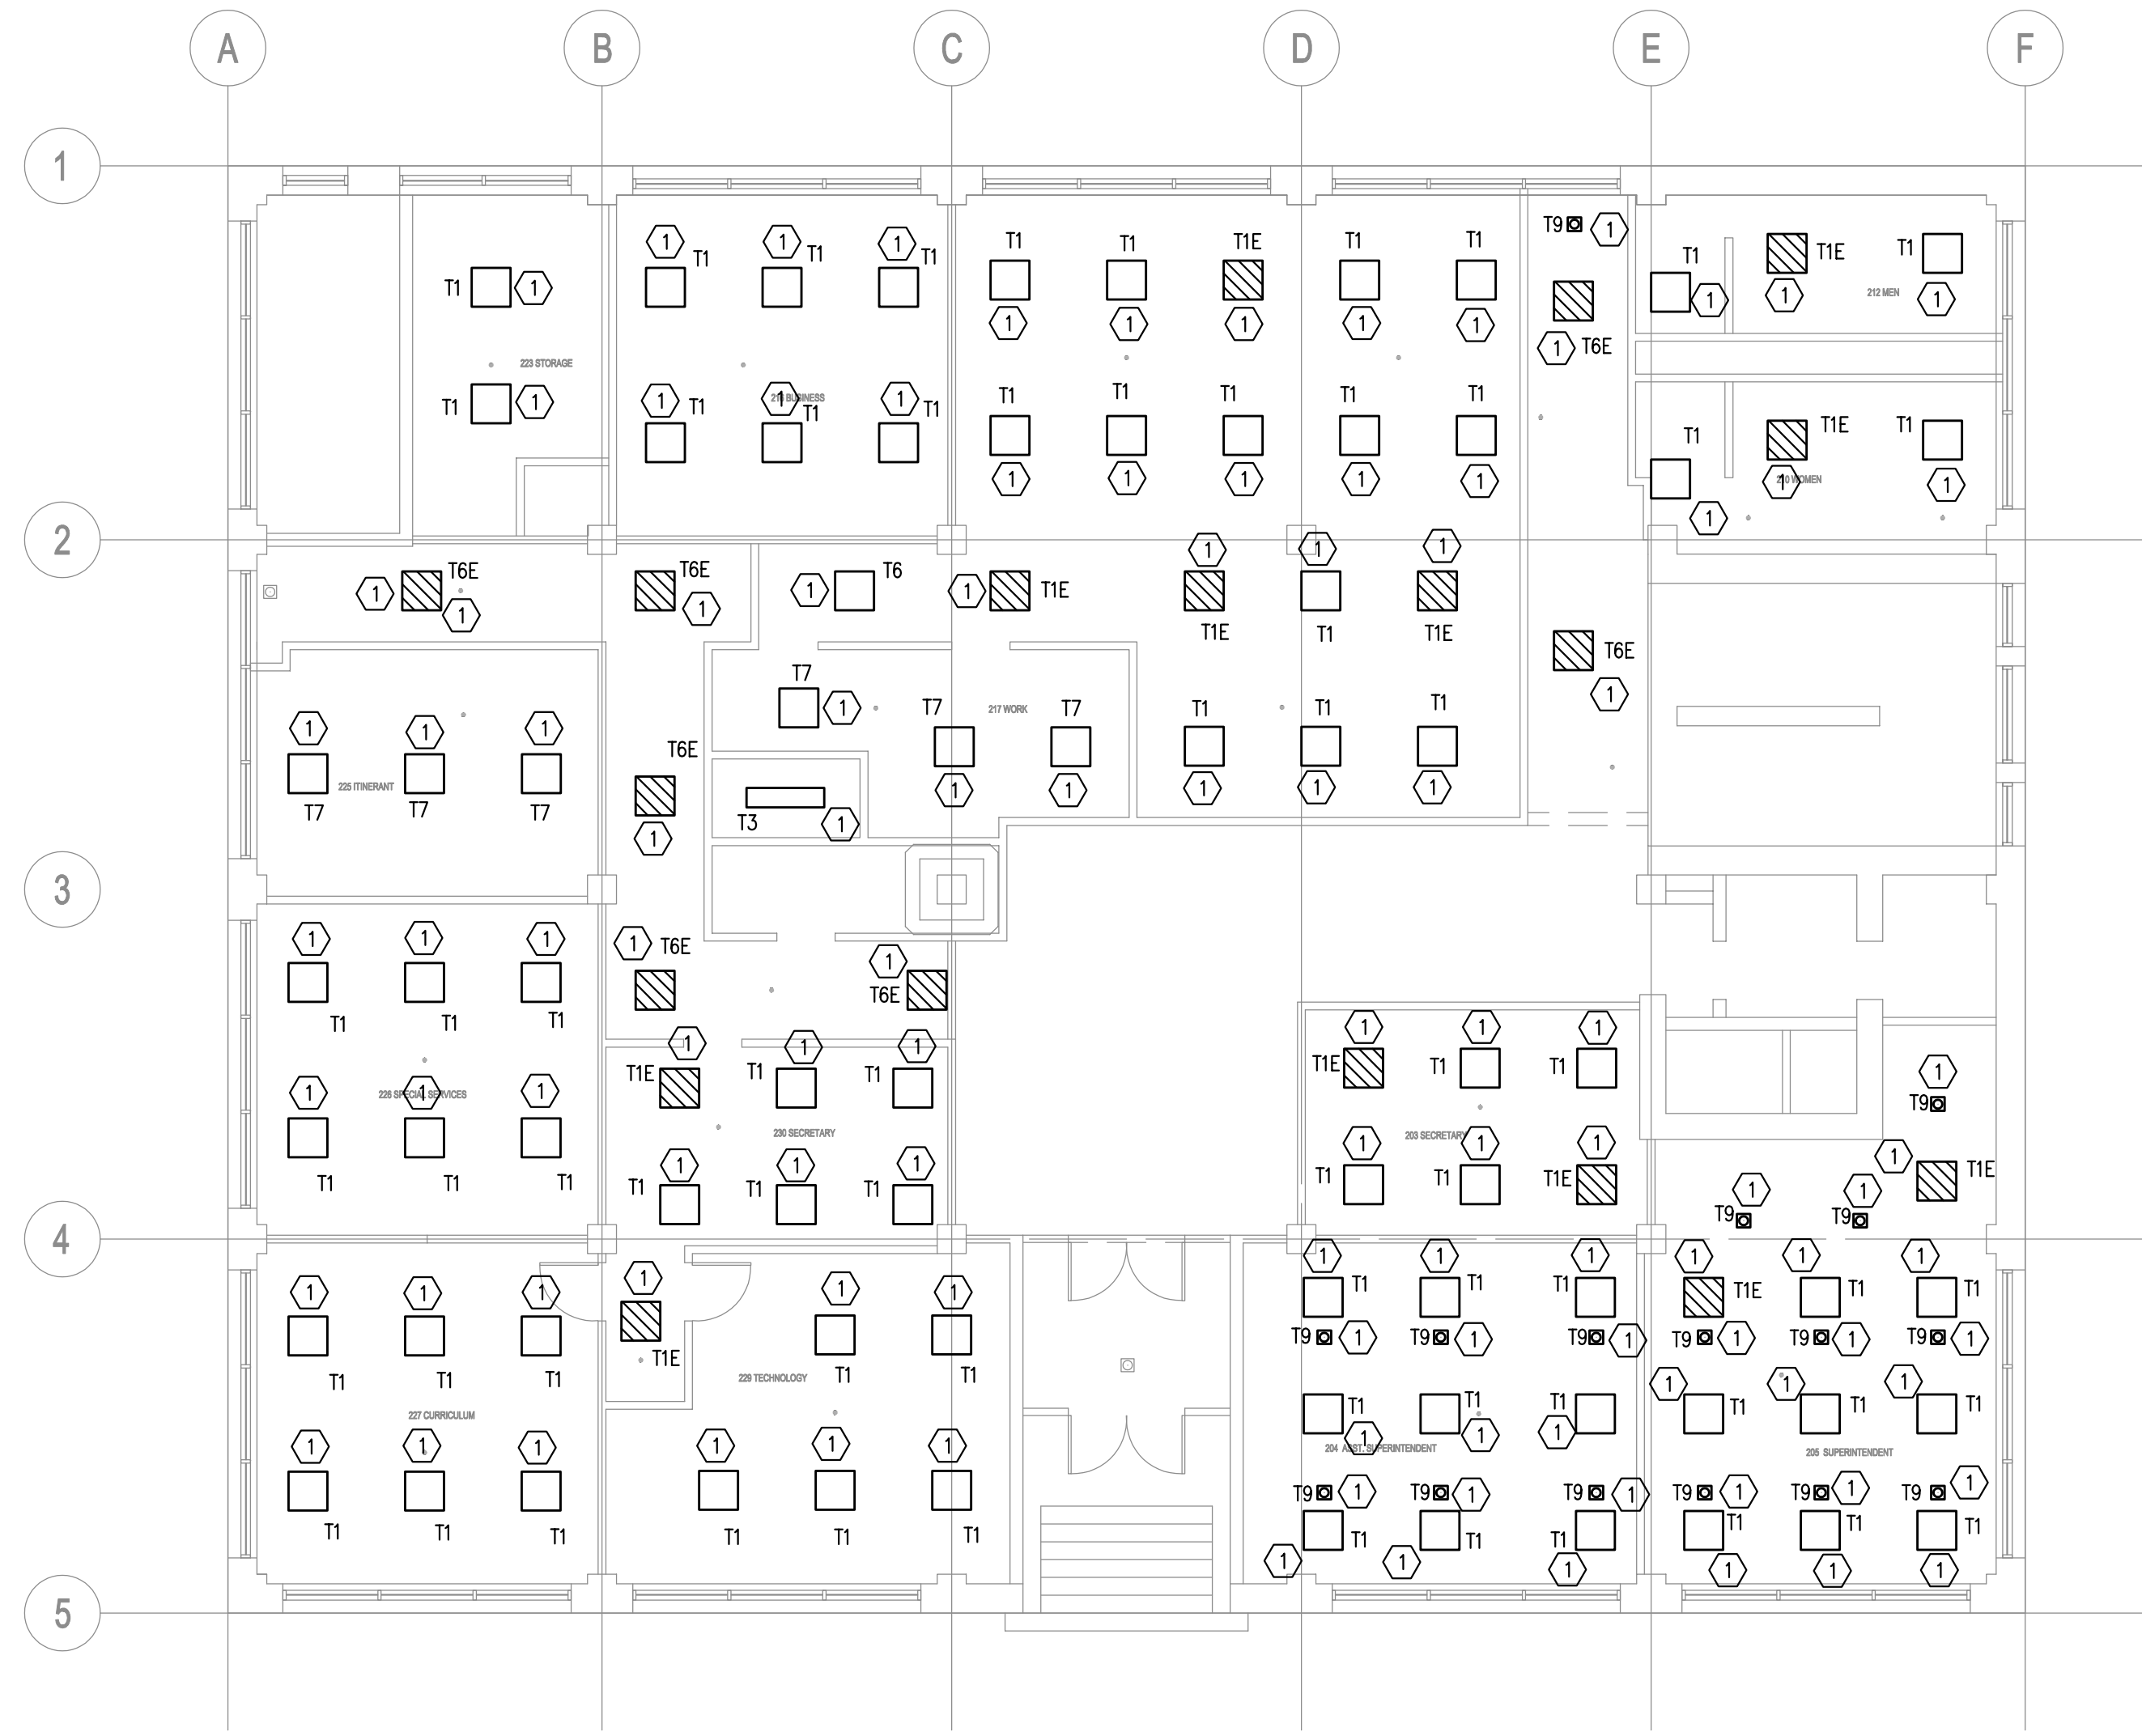

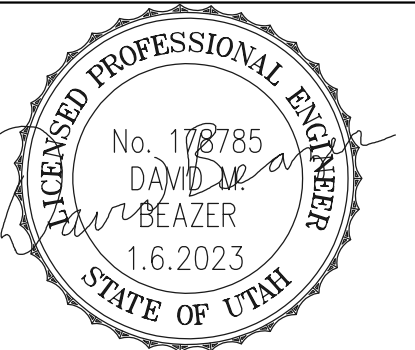

BEAZER ENGINEERING INC.
 P.O. BOX 652
 MILLVILLE, UTAH 84326
 C 435.770.8999
 david@beazer-engineering.com

OWNERSHIP OF DOCUMENTS
 These documents, including the designs and ideas incorporated herein, are the property of BEAZER ENGINEERING, INC. and shall not be used, in whole or in part, for any other project without written permission.

DATE
 Jan 6, 2023

PROJECT TITLE
 Logan City School District
 Main Office Remodel
 101 West Center
 Logan, Utah 84321

SHEET TITLE
 UPPER FLOOR
 LIGHTING PLAN

PROJECT NUMBER

REVISIONS

SHEET NUMBER

E1.3

KEYED NOTES (F)

1. REPLACE EXISTING FIXTURE WITH NEW IN APPROXIMATELY SAME LOCATION.
2. NEW FIXTURE LOCATION.
3. REPLACE "A" LAMP WITH 15W LED A21 LAMP.

| LIGHT FIXTURE SCHEDULE | | | |
|------------------------|---|--------------------------|-----------|
| TYPE | MANUFACTURER/CATALOG NO. | MOUNTING | LAMPS |
| T1 | LITHONIA EPANL 2X2 3400LM 80CRI 35K MIN10 ZT MVOLT | T-BAR | LED (30W) |
| T1E | SAME AS T1 WITH E10WCP EMERGENCY BATTERY PACK | T-BAR | LED (30W) |
| T2 | LITHONIA CLX L48 3000LM SEF WDL MVOLT G210 35KI 80CRI | SURFACE OR CHAIN SUSPEND | LED (19W) |
| T2E | SAME AS T2 WITH E10WCP EMERGENCY BATTERY PACK | SURFACE OR CHAIN SUSPEND | LED (19W) |
| T3 | LITHONIA STL4 30L MVOLT E21 LP835 | SURFACE | LED (27W) |
| T3E | SAME AS T3 WITH EL14L EMERGENCY BATTERY PACK | SURFACE | LED (27W) |
| T4 | LITHONIA STL4 60L MVOLT E21 LP835 | SURFACE | LED (53W) |
| T5 | LITHONIA STL2 20L MVOLT E21 LP835 | SURFACE | LED (20W) |
| T6 | LITHONIA EPANL 2X2 4000LM 80CRI 35K MIN10 ZT MVOLT | T-BAR | LED (37W) |
| T6E | SAME AS T6 WITH E10WCP EMERGENCY BATTERY PACK | T-BAR | LED (37W) |
| T7 | LITHONIA EPANL 2X2 4800LM 80CRI 35K MIN10 ZT MVOLT | T-BAR | LED (45W) |
| T8 | BATHROOM WALL ABOVE MIRROR | WALL ABOVE MIRROR | LED (30W) |
| T9 | GOHAM EVO 35/15 AR LD WD MVOLT G21 | RECESS | LED (15W) |

EQUAL FIXTURES WITH SIMILAR LUMENS APPROVED BY OWNER ARE ACCEPTABLE

